


SIXTH FLOOR PLAN


Scale	Project	Revision	Checked by
1:300 in A3	TECHNOLOGICAL AND HIGHER EDUCATION INSTITUTE OF HONG KONG (TSING YI)		
Date	Drawing Title		Drawn by
1-Oct-2014	SIXTH FLOOR PLAN	Job no.	Jack IP
	THEI(TY)-BP-08		

VOCATIONAL TRAINING COUNCIL
 EST. ATES, HEALTH & SAFETY DIVISION
 12/F VTC TOWER, 27 WOOD ROAD, WANCHAI, H.K.
 TEL : 28937849 FAX : 28937849

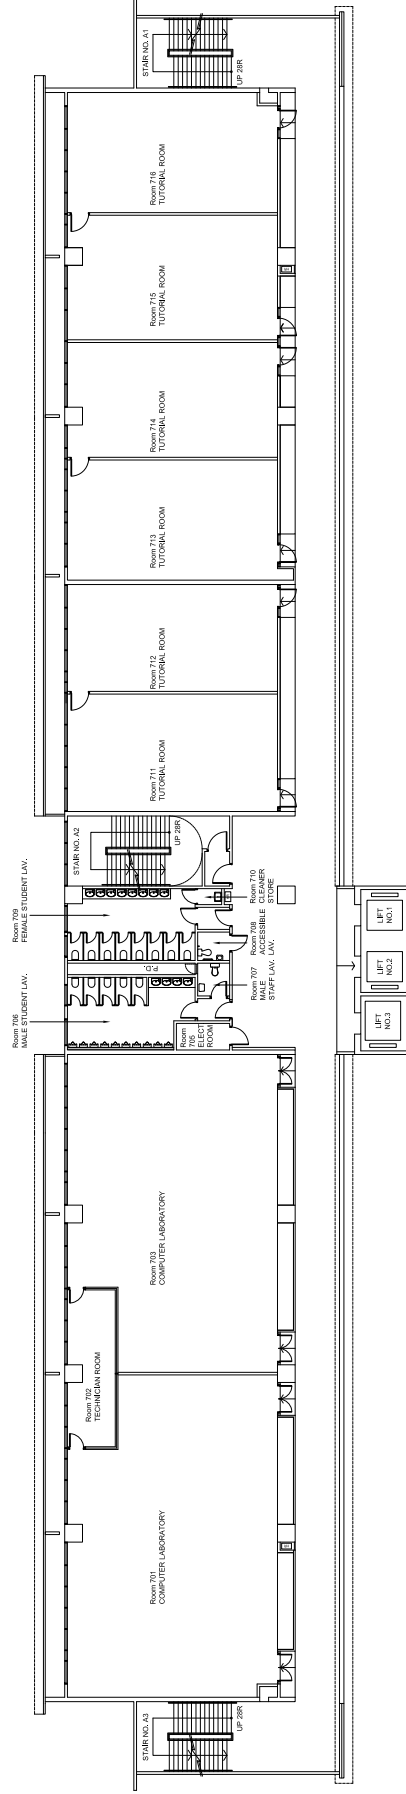

SEVENTH FLOOR PLAN

Scale	Project		Checked by	Revision	
1:300 in A3	TECHNOLOGICAL AND HIGHER EDUCATION INSTITUTE OF HONG KONG (TSING YI)				
Date	Drawing Title	Drawing no.	Drawn by	Job no.	
1-Oct-2014	SEVENTH FLOOR PLAN	THEI(TY)-BP-09	Jack IP		
			VOCATIONAL TRAINING COUNCIL EST. ATES. HEALTH & SAFETY DIVISION 12/F VTC TOWER, 27 WOOD ROAD, WANCHAI, H.K. TEL.: 28937849 FAX.: 28937849		

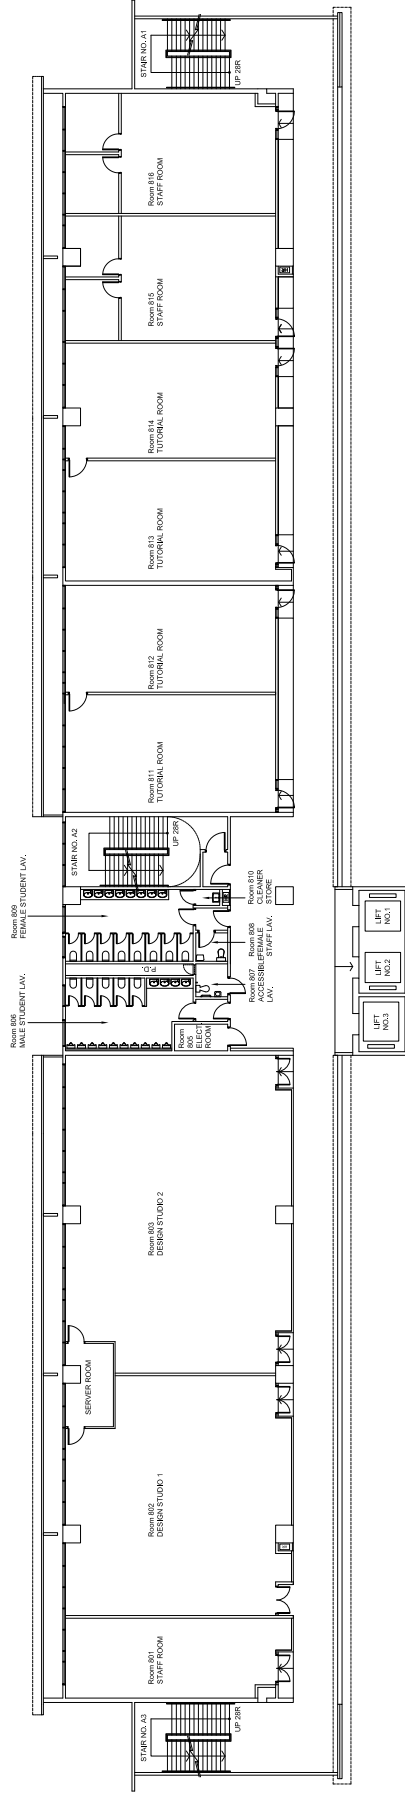

EIGHTH FLOOR PLAN

Scale	Project		Checked by	Revision
1:300 in A3	TECHNOLOGICAL AND HIGHER EDUCATION INSTITUTE OF HONG KONG (TSING YI)			
Date	Drawing Title	Drawing no.	Drawn by	Job no.
1-Oct-2014	EIGHTH FLOOR PLAN	THEI(TY)-BP-10	Jack IP	

**VOCATIONAL
TRAINING
COUNCIL**

ESTATES, HEALTH
& SAFETY DIVISION
12/F VTC TOWER, 27 WOOD ROAD, WANCHAI, H.K.
TEL : 28937849
FAX : 28937800